


DUAL DT LANES CANOPY POWER WIRING SCHEMATIC - NEW MLOP


NO SCALE

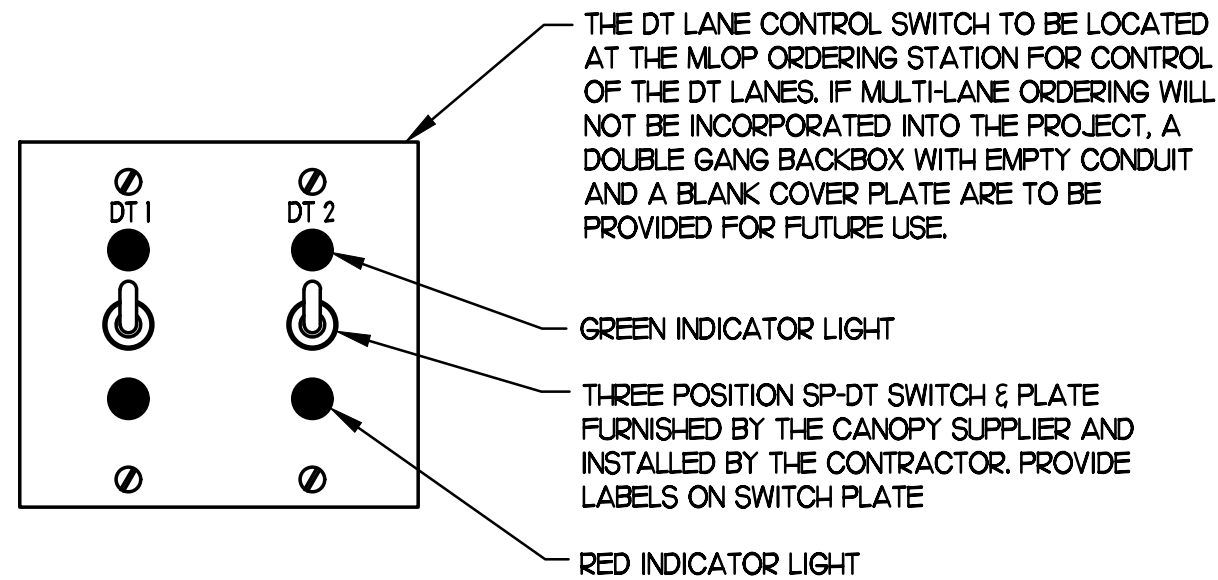

3 POSITION DT LANE CONTROL STATION


NO SCALE

MULTI-LANE ORDER POINT (MLOP) DRIVE-THRU REQUIREMENTS

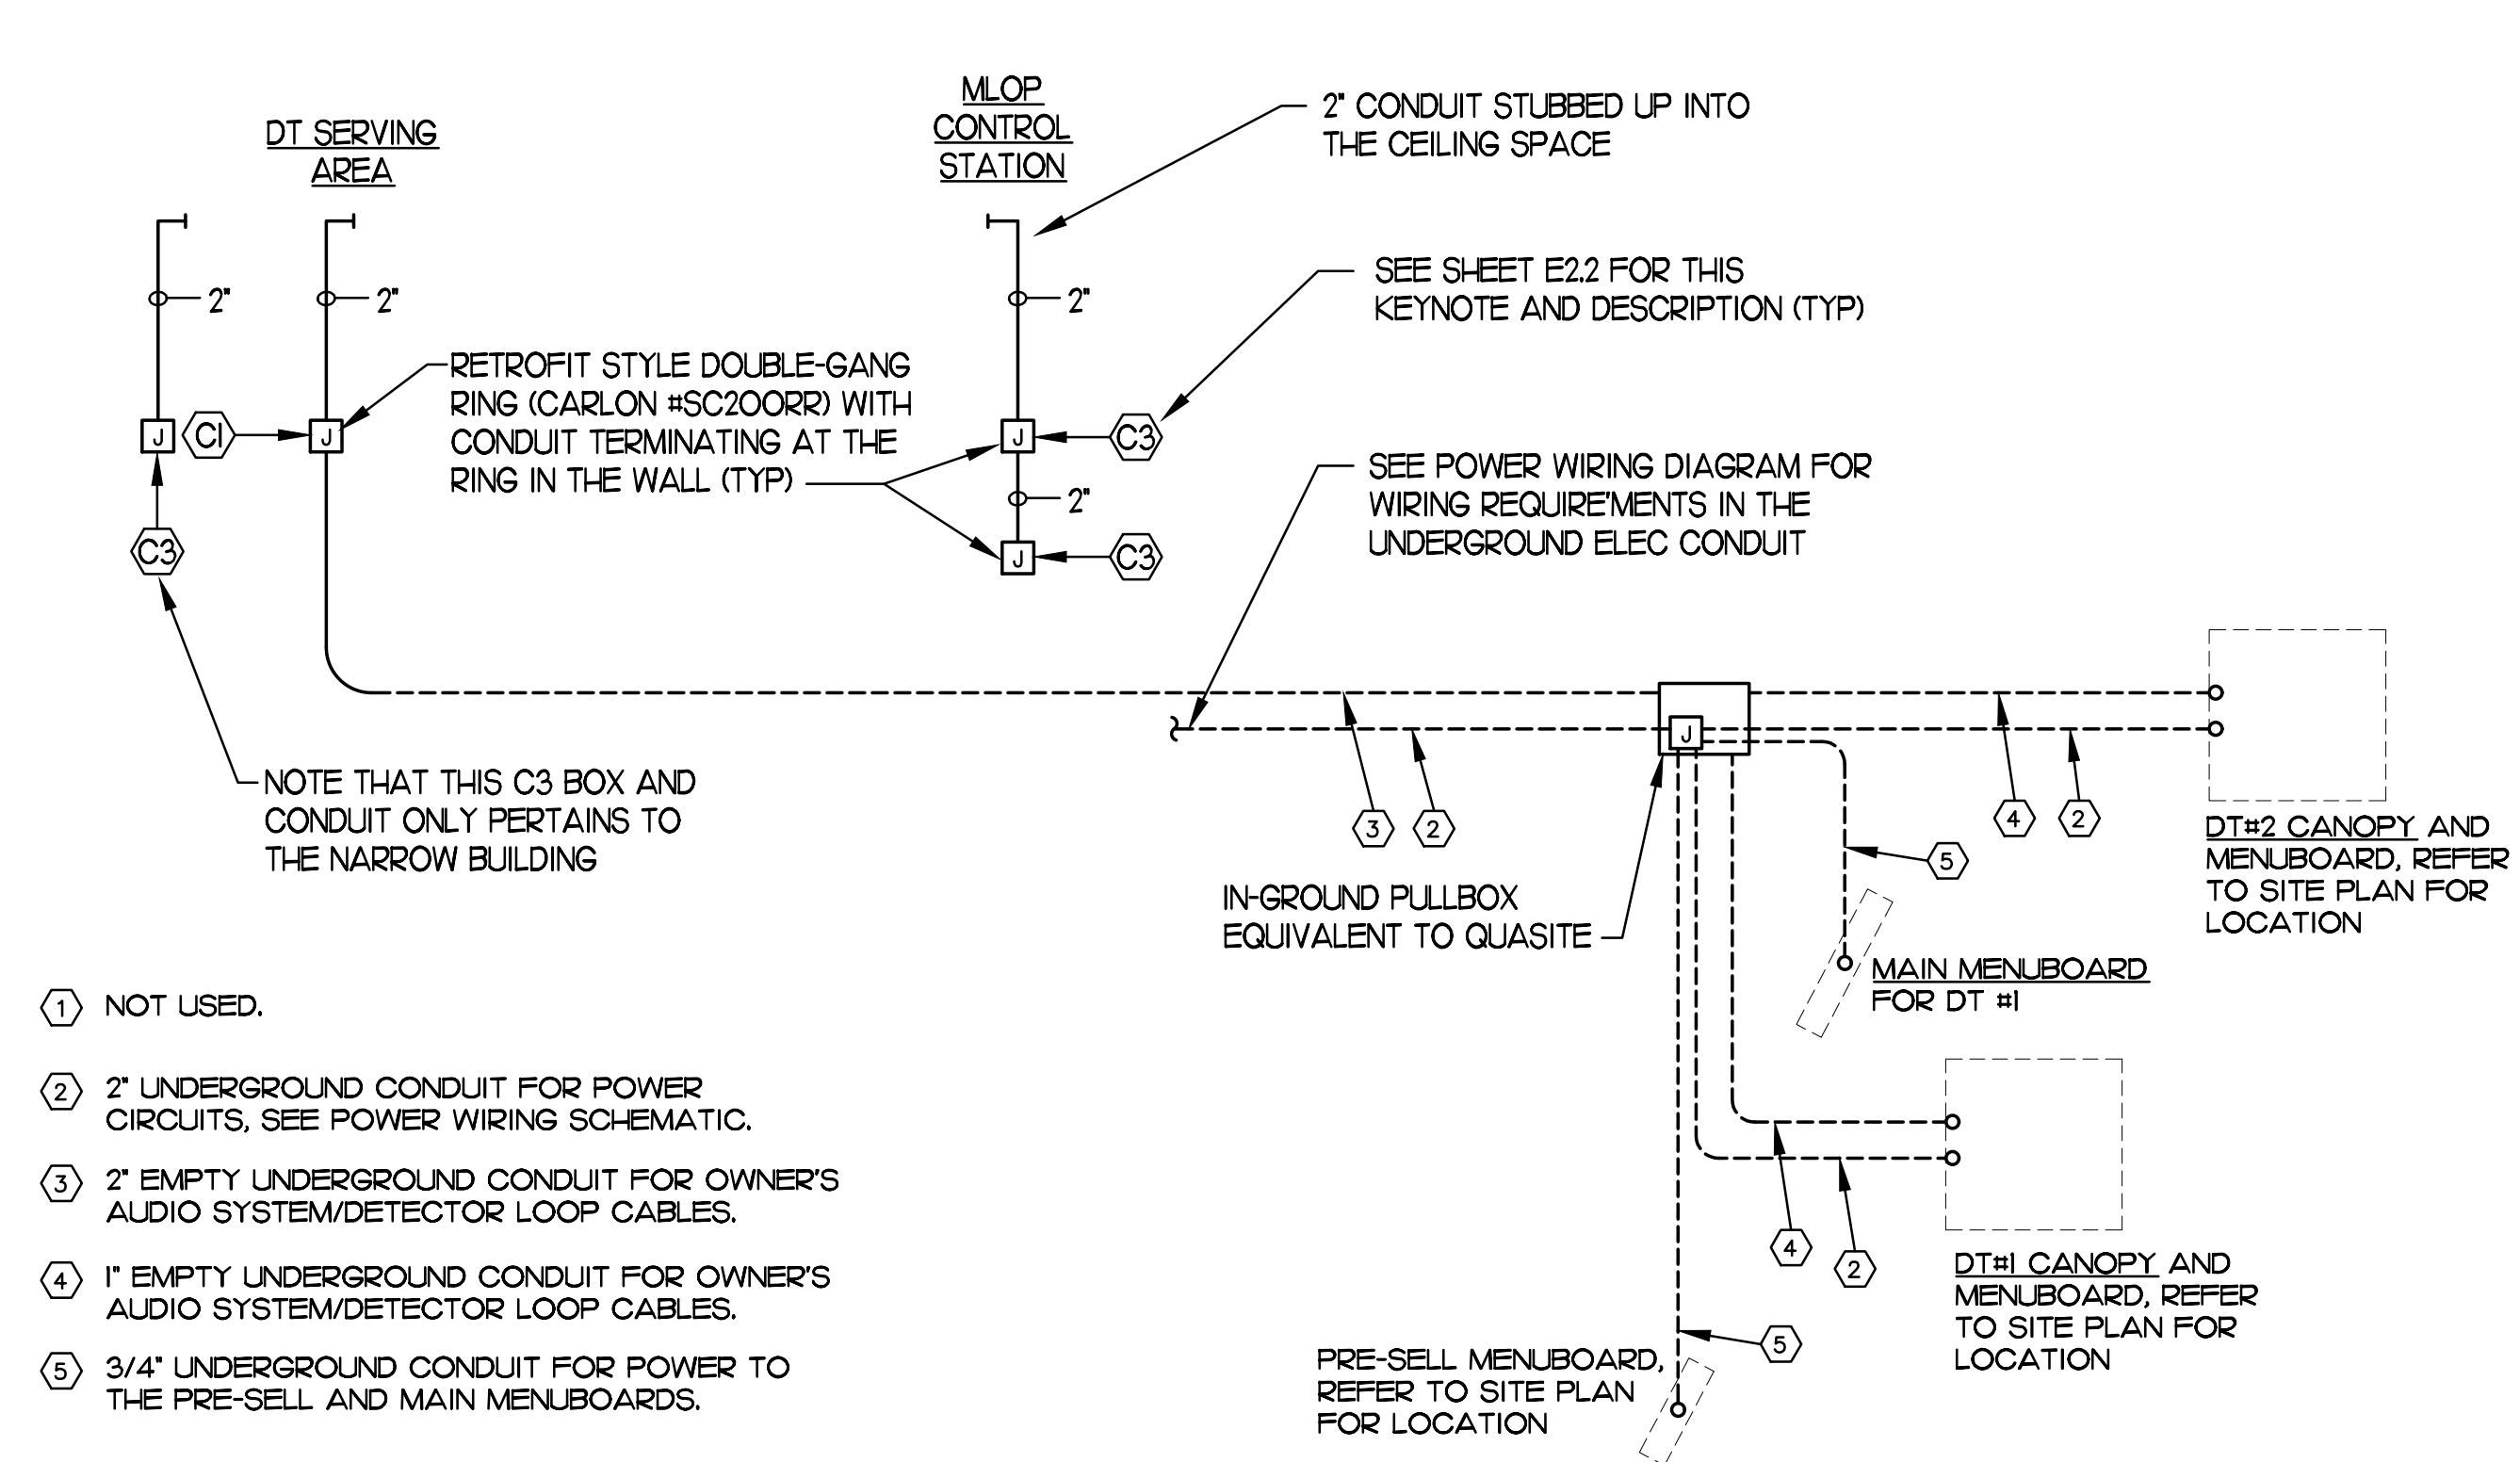


MULTI-LANE DRIVE-THRU ORDER AREA CONDUIT REQUIREMENTS

NO SCALE

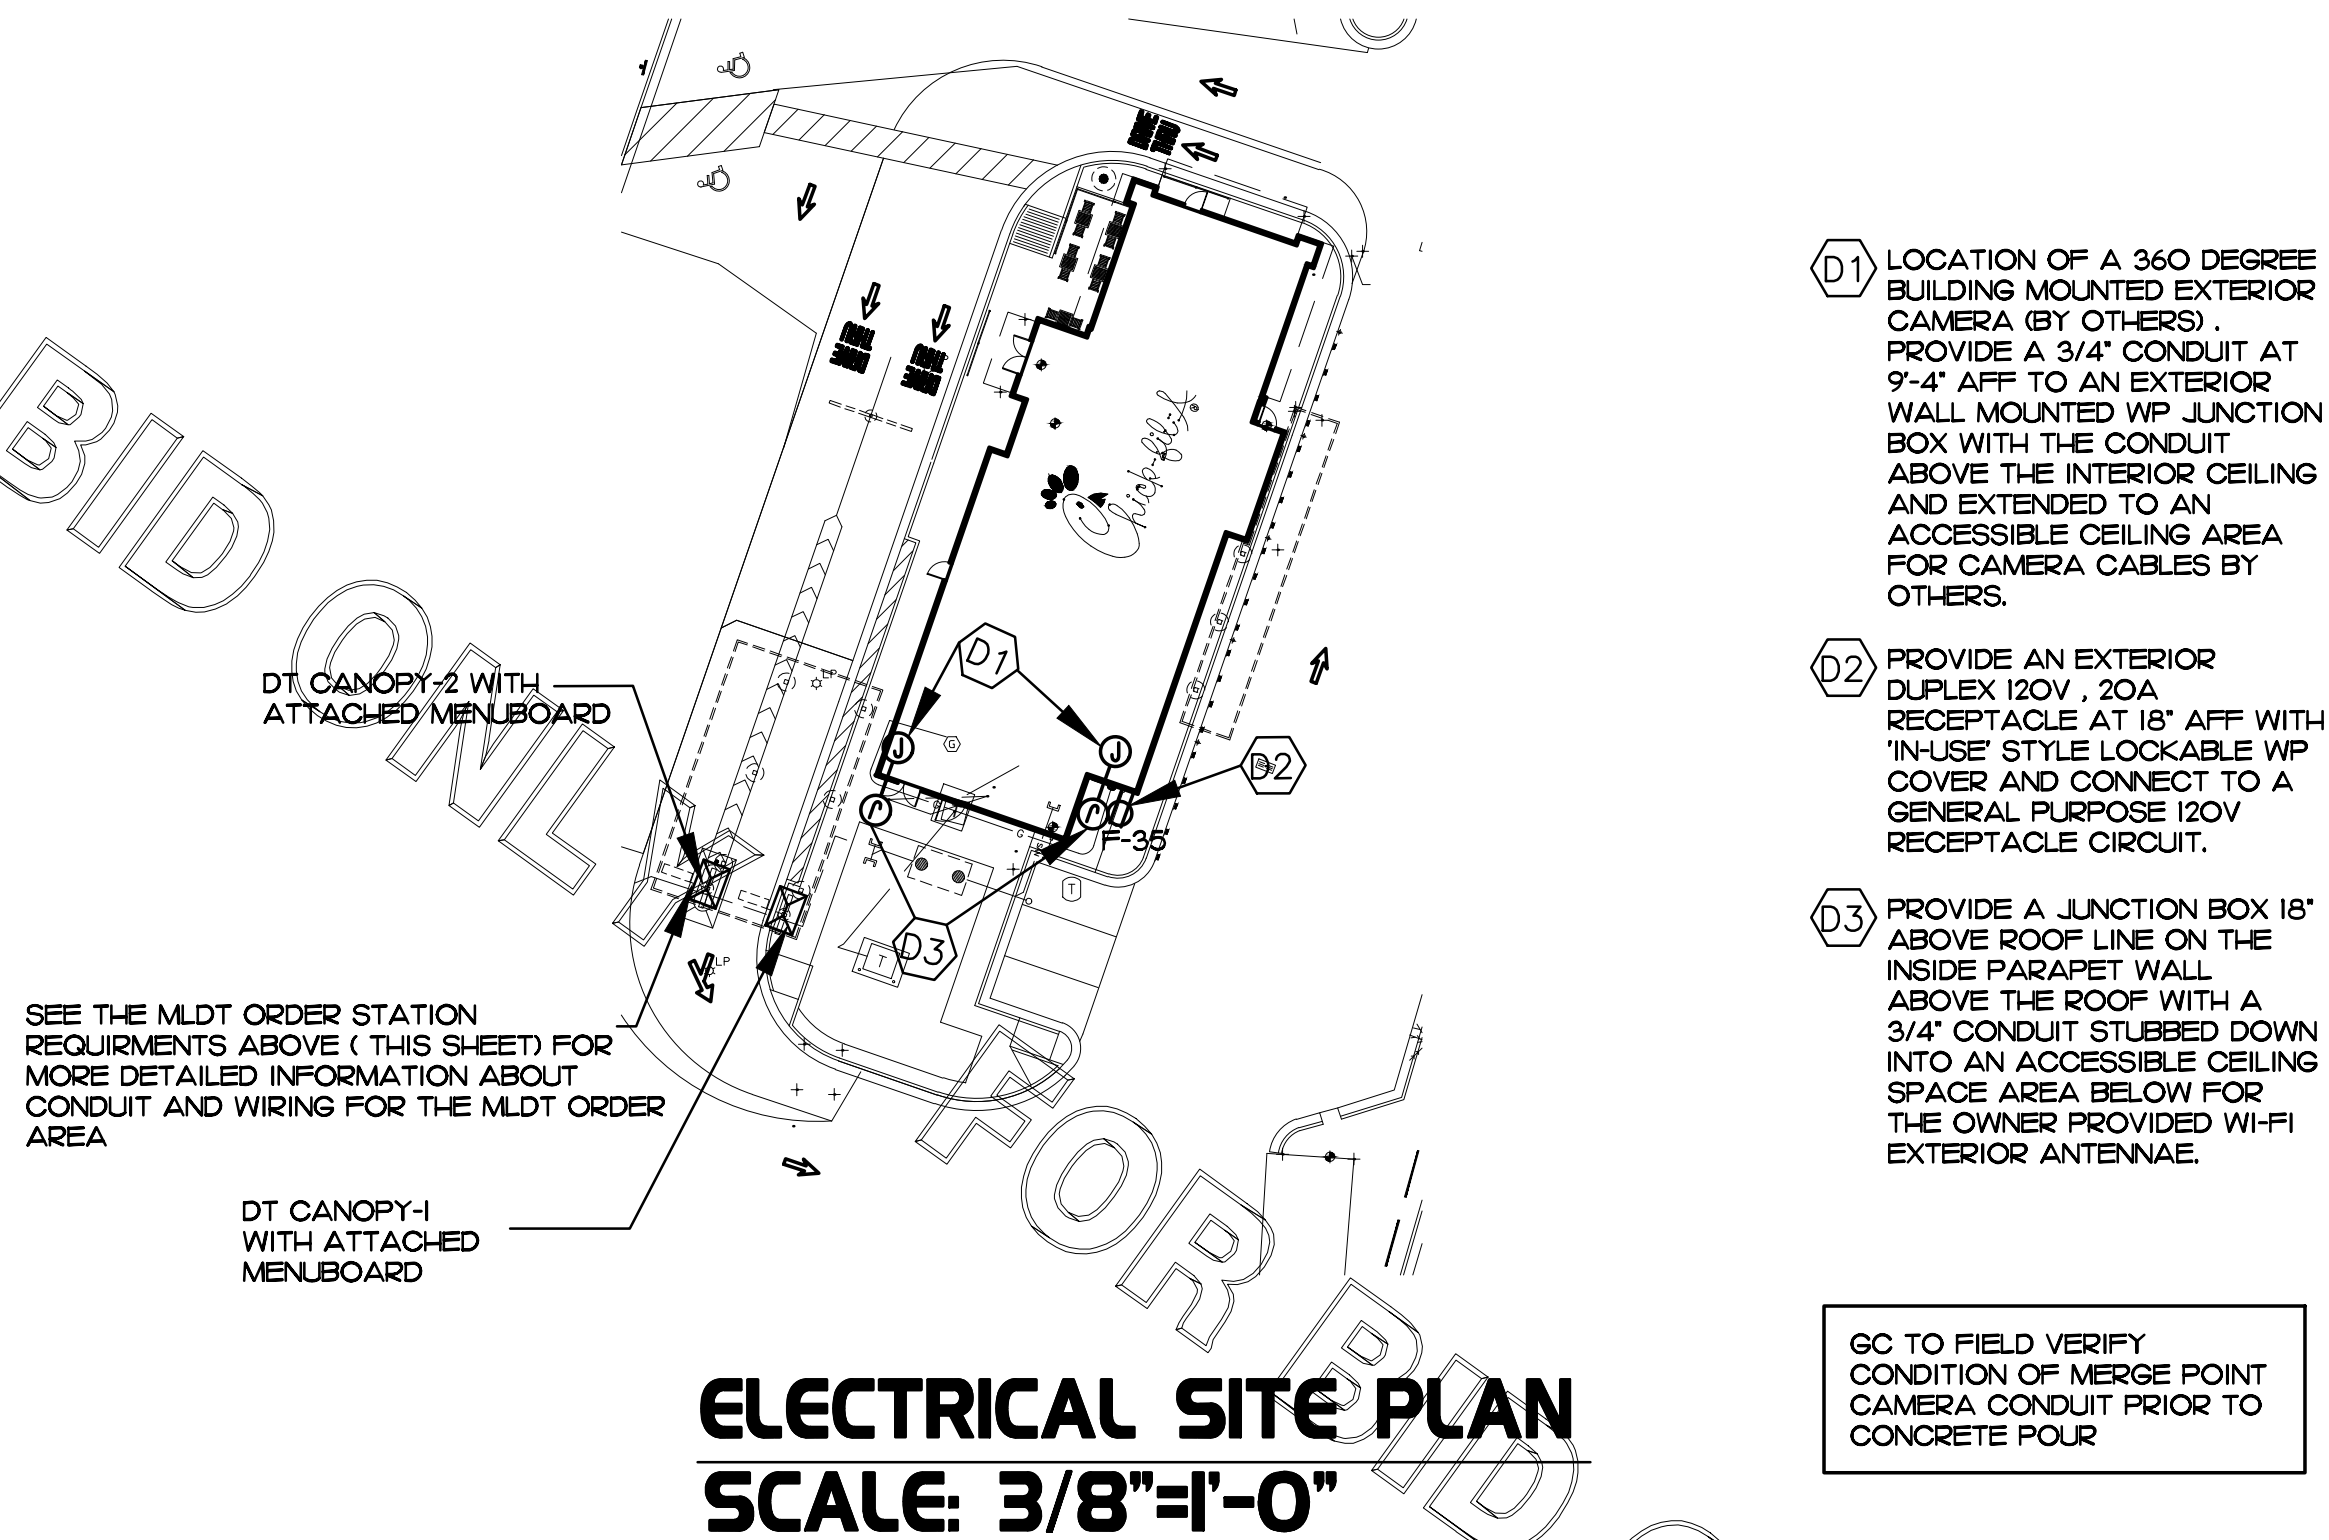

ELECTRICAL SITE PLAN
SCALE: 3/8"=1'-0"

GC TO FIELD VERIFY
CONDITION OF MERGE POINT
CAMERA CONDUIT PRIOR TO
CONCRETE POUR

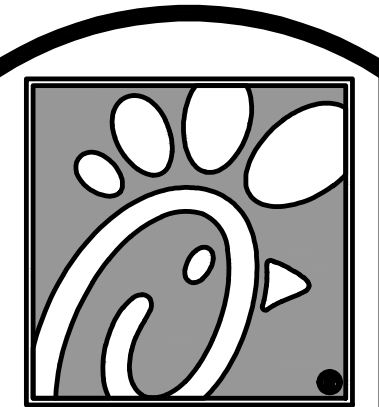

Chick-fil-A

5200 Buffington Rd.
Atlanta Georgia,
30349-2998

Revisions:

Mark Date By

△

△

△

△

△

SEAL
THIS DOCUMENT IS NOT FOR CONSTRUCTION
UNLESS THE ARCHITECT OR ENGINEER'S
SIGNATURE AND SEAL APPEAR BELOW.

STACY HENSON, P.E.

INTERPLAN

ARCHITECTURE
INTERIOR DESIGN
PROJECT MANAGEMENT

604 COURTLAND STREET
SUITE 100
ORLANDO, FLORIDA 32804
PH 407.645.5008
FX 407.629.9124

STORE
UNIVERSITY DRIVE
FSU
SERIES 100 BARREL
4733 UNIVERSITY DR
NW
HUNTSVILLE, AL
35816

SHEET TITLE
DRIVE-THRU
ORDER DETAILS

VERSION: 2017-042
ISSUE DATE: 11/13/17

Job No. : 17.0180

Store : 0870

Date : 03/1/18

Drawn By : MI

Checked By : SN

Sheet

E.I.3

COPYRIGHT © 2017 INTERPLAN LLC RESERVES COPYRIGHT & OTHER RIGHTS RESTRICTING THESE DOCUMENTS TO THE ORIGINAL SITE OR PURPOSE FOR WHICH THEY WERE PREPARED. REPRODUCTIONS, CHANGES OR ASSIGNMENTS ARE PROHIBITED.